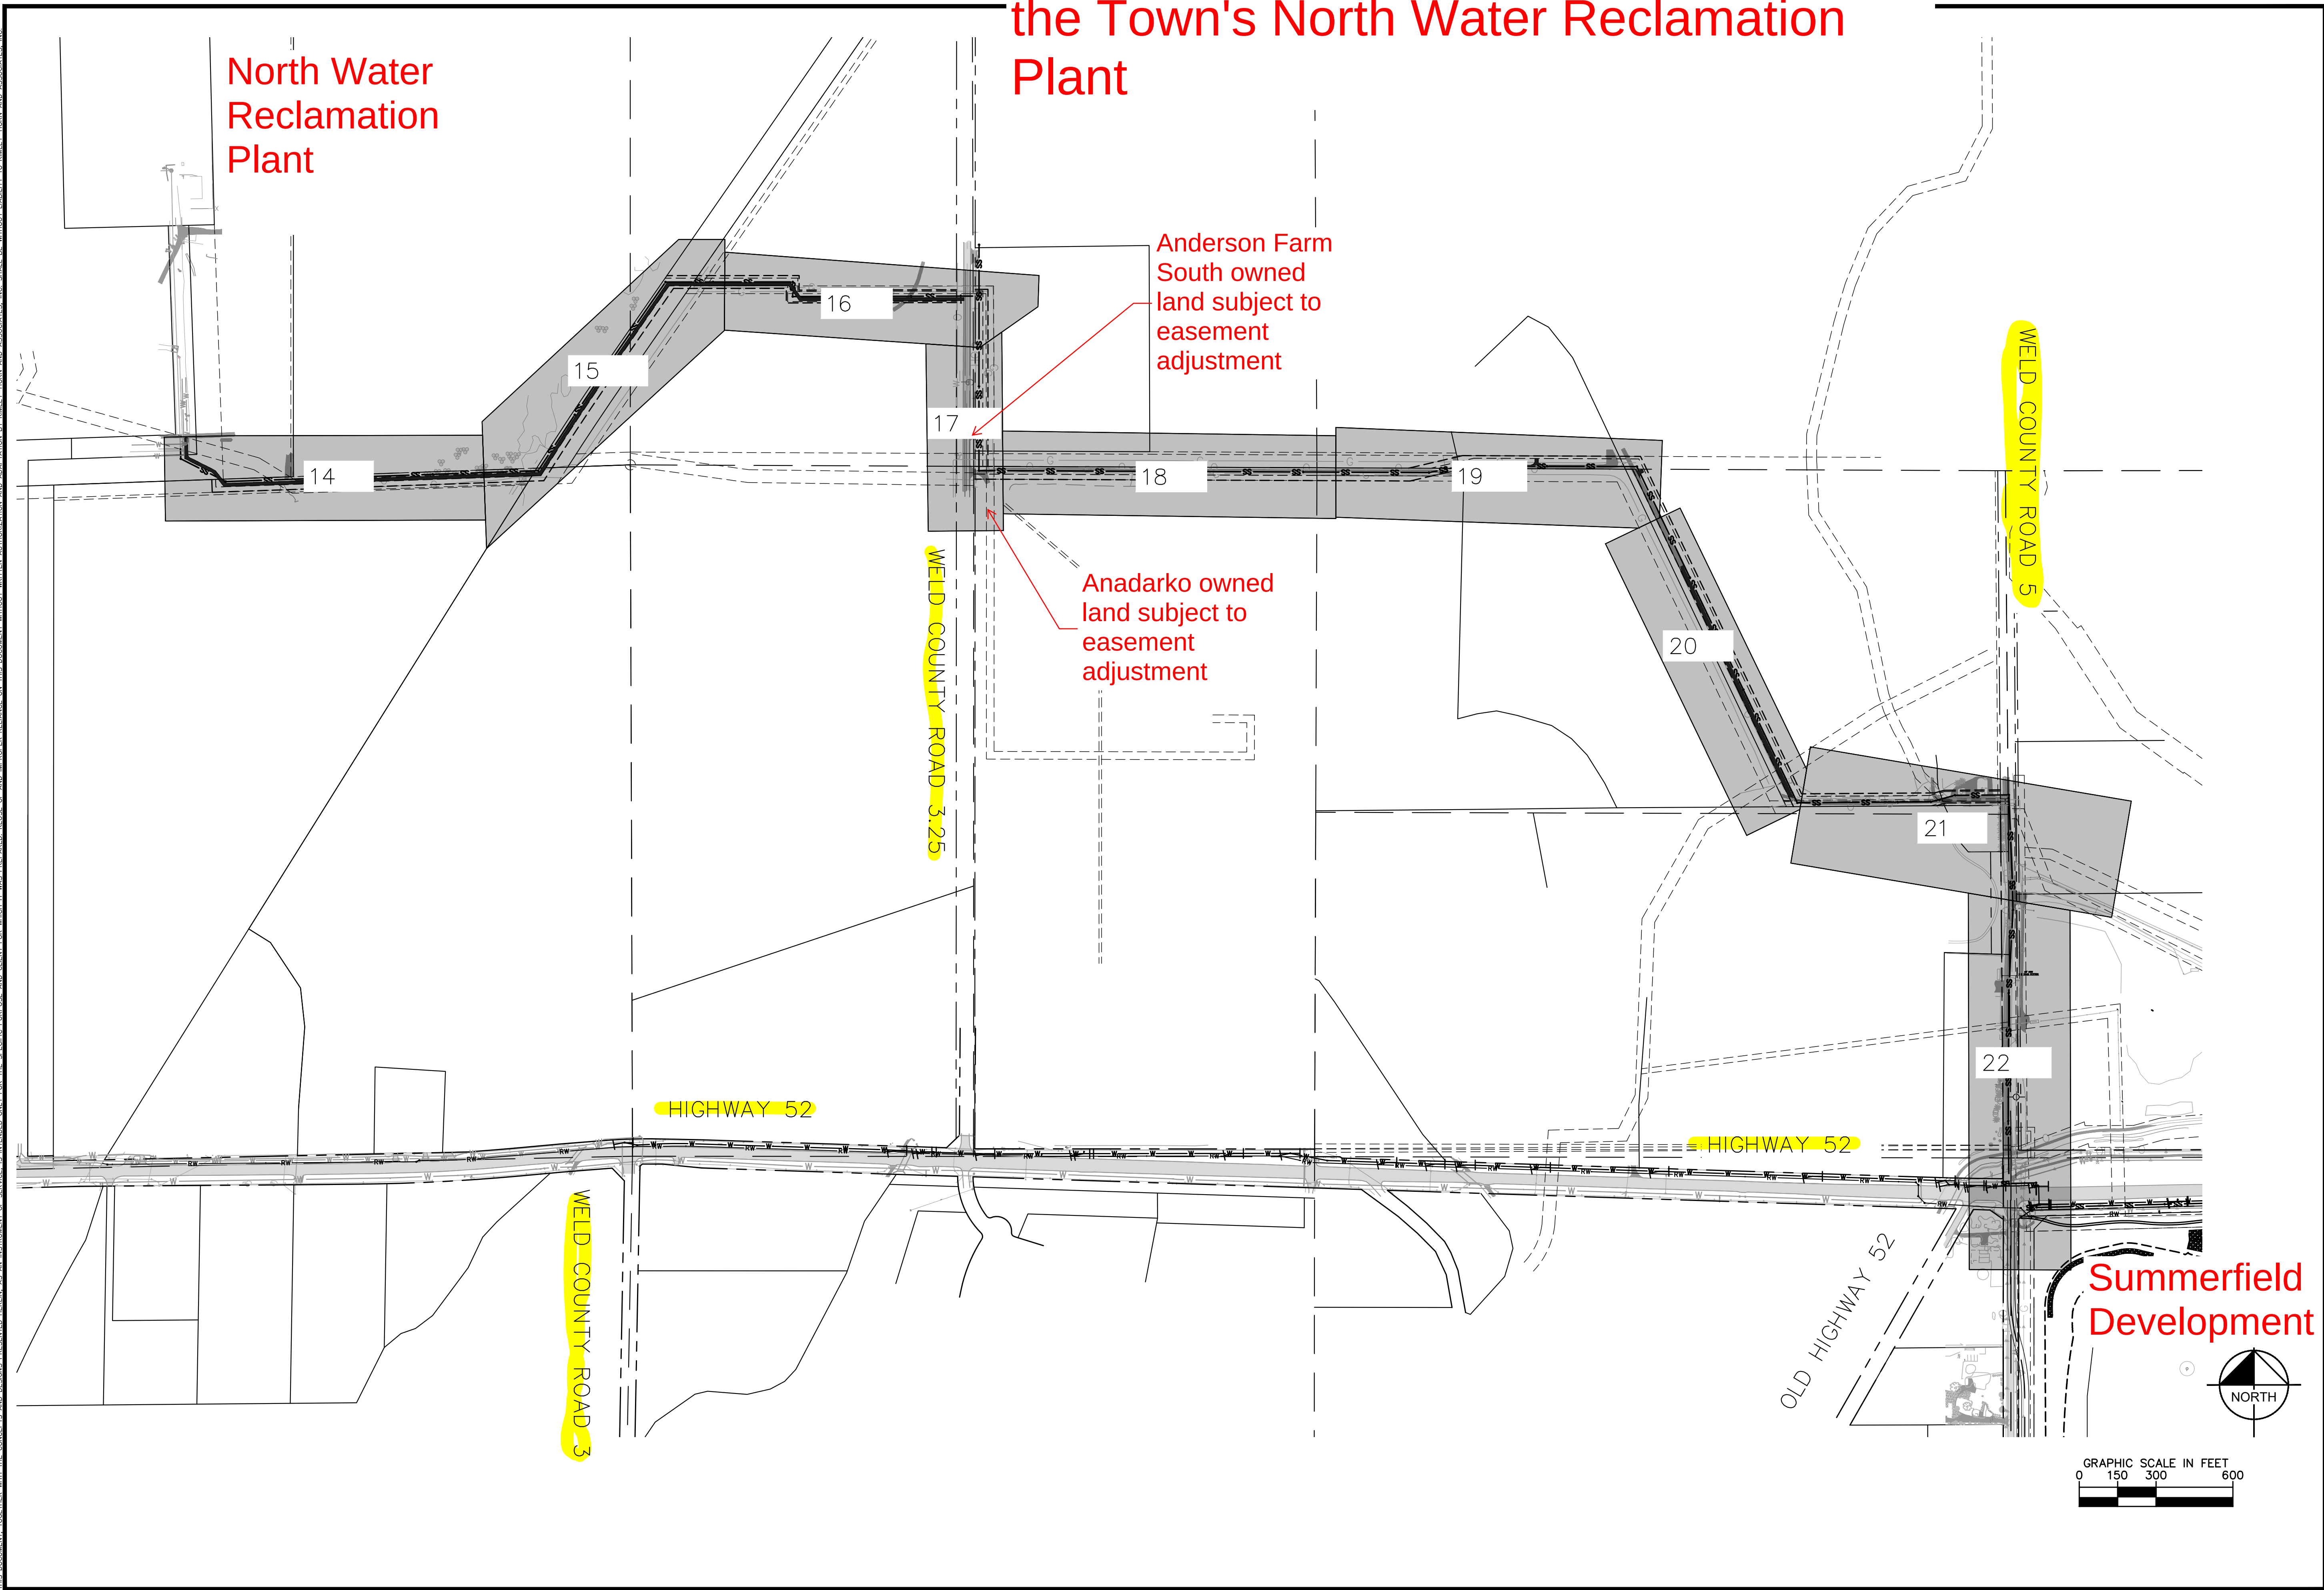


K:\DEV\_Civil\096761001\_Summerfield\CAD\PlanSheet\Final\Plot\01.dwg, 5/10/2023, 5:18 PM  
THIS DOCUMENT, INCLUDING THE CONCEPT AND DESIGN PRESENTED HEREIN, IS THE PROPERTY OF KIMLEY-HORN AND ASSOCIATES, INC. AND IS TO BE USED ONLY FOR THE SPECIFIC PROJECT AND CLIENT FOR WHICH IT WAS PREPARED. NO PART OF THIS DOCUMENT MAY BE REPRODUCED OR TRANSMITTED IN ANY FORM OR BY ANY MEANS, ELECTRONIC OR MECHANICAL, WITHOUT WRITTEN AUTHORIZATION AND ADAPTATION BY KIMLEY-HORN AND ASSOCIATES, INC. SHALL BE WITHOUT LIABILITY TO KIMLEY-HORN AND ASSOCIATES, INC.



Sewer line (in gray) from Summerfield to the Town's North Water Reclamation Plant

|                                                                                                                                                    |                                     |
|----------------------------------------------------------------------------------------------------------------------------------------------------|-------------------------------------|
| <b>Kimley»Horn</b>                                                                                                                                 |                                     |
| DESIGNED BY: KPB<br>DRAWN BY: WFK<br>CHECKED BY: KPB<br>DATE: 09/16/2022                                                                           |                                     |
| SUMMERFIELD - FILING NO. 1<br>TOWN OF ERIE, COUNTY OF WELD, COLORADO<br>OVERALL OFFSITE SANITARY SEWER PLAN<br>OFF-SITE UTILITY CONSTRUCTION PLANS |                                     |
| PROJECT NO.<br>096761001                                                                                                                           | 3RD SUBMITTAL<br>WFK/5/12/23<br>KPB |
| DRAWING NAME<br>OFFSITE SANITARY                                                                                                                   | 2ND SUBMITTAL<br>WFK/3/10/23<br>KPB |
| 13                                                                                                                                                 | 1ST SUBMITTAL<br>WFK/9/16/22<br>KPB |
|                                                                                                                                                    | NO. BY DATE APPR                    |

K:\DEN\_Civil\096761001\_Summerfield\CA00\PlanSheets\Final Plots\Filing No. 1\0ffsite Son Sewer P&P\Offsite Sanitary Plan Sheets.dwg Finley, Maddie 9/10/2025 4:29 PM



UTI

- 1.
- 2.
- 3.
- 4.

00.0  
-1M-  
PRIVATE  
STAL  
NHOL  
717.6  
915.9

— — —  
— — —

OVE

E

494.8

2+00

 
 
 
ER

1. 2. 3. 4. 00.00 -1M- VATE STALL WHOL 17.6 15.9

5.  
6.  
7.  
8.  
9.  
10.
- 2.34  
-1M  
ALL:  
HOLE  
7.65  
5.87
- SS +
- SEE  
(FE)
- SE

EXI  
1.  
P E  
1  
P. 50  
FEN  
345  
SS  
EX  
GR  
BOVE  
1  
00

- EXISTING  
GROUND  
GRADE
- 1
- 100

[illegible]

|  |        |   |                                                                                       |                           |                          |           |
|--|--------|---|---------------------------------------------------------------------------------------|---------------------------|--------------------------|-----------|
|  | D<br>O | F |  | SIMMERBEI D - EILING NO 1 | DES<br>DRA<br>CHE<br>DAT | Vim   ... |
|--|--------|---|---------------------------------------------------------------------------------------|---------------------------|--------------------------|-----------|

|  |        |   |                                                                                       |                         |                          |
|--|--------|---|---------------------------------------------------------------------------------------|-------------------------|--------------------------|
|  | D<br>O | F |  | SILVEREID - EILING NO 1 | DES<br>DRA<br>CHE<br>DAT |
|--|--------|---|---------------------------------------------------------------------------------------|-------------------------|--------------------------|

|  |           |    |                                                                                       |                           |
|--|-----------|----|---------------------------------------------------------------------------------------|---------------------------|
|  | Dr.<br>O. | F. |  | SUMMERBEI D - EILING NO 1 |
|--|-----------|----|---------------------------------------------------------------------------------------|---------------------------|



PR  
O  
DRA  
OFFS

DRA  
OFFS

17