



LAST SAVED: 6/6/2018 2:24 PM

G:\23318\23318 SITE\23318-SITE-2.dwg

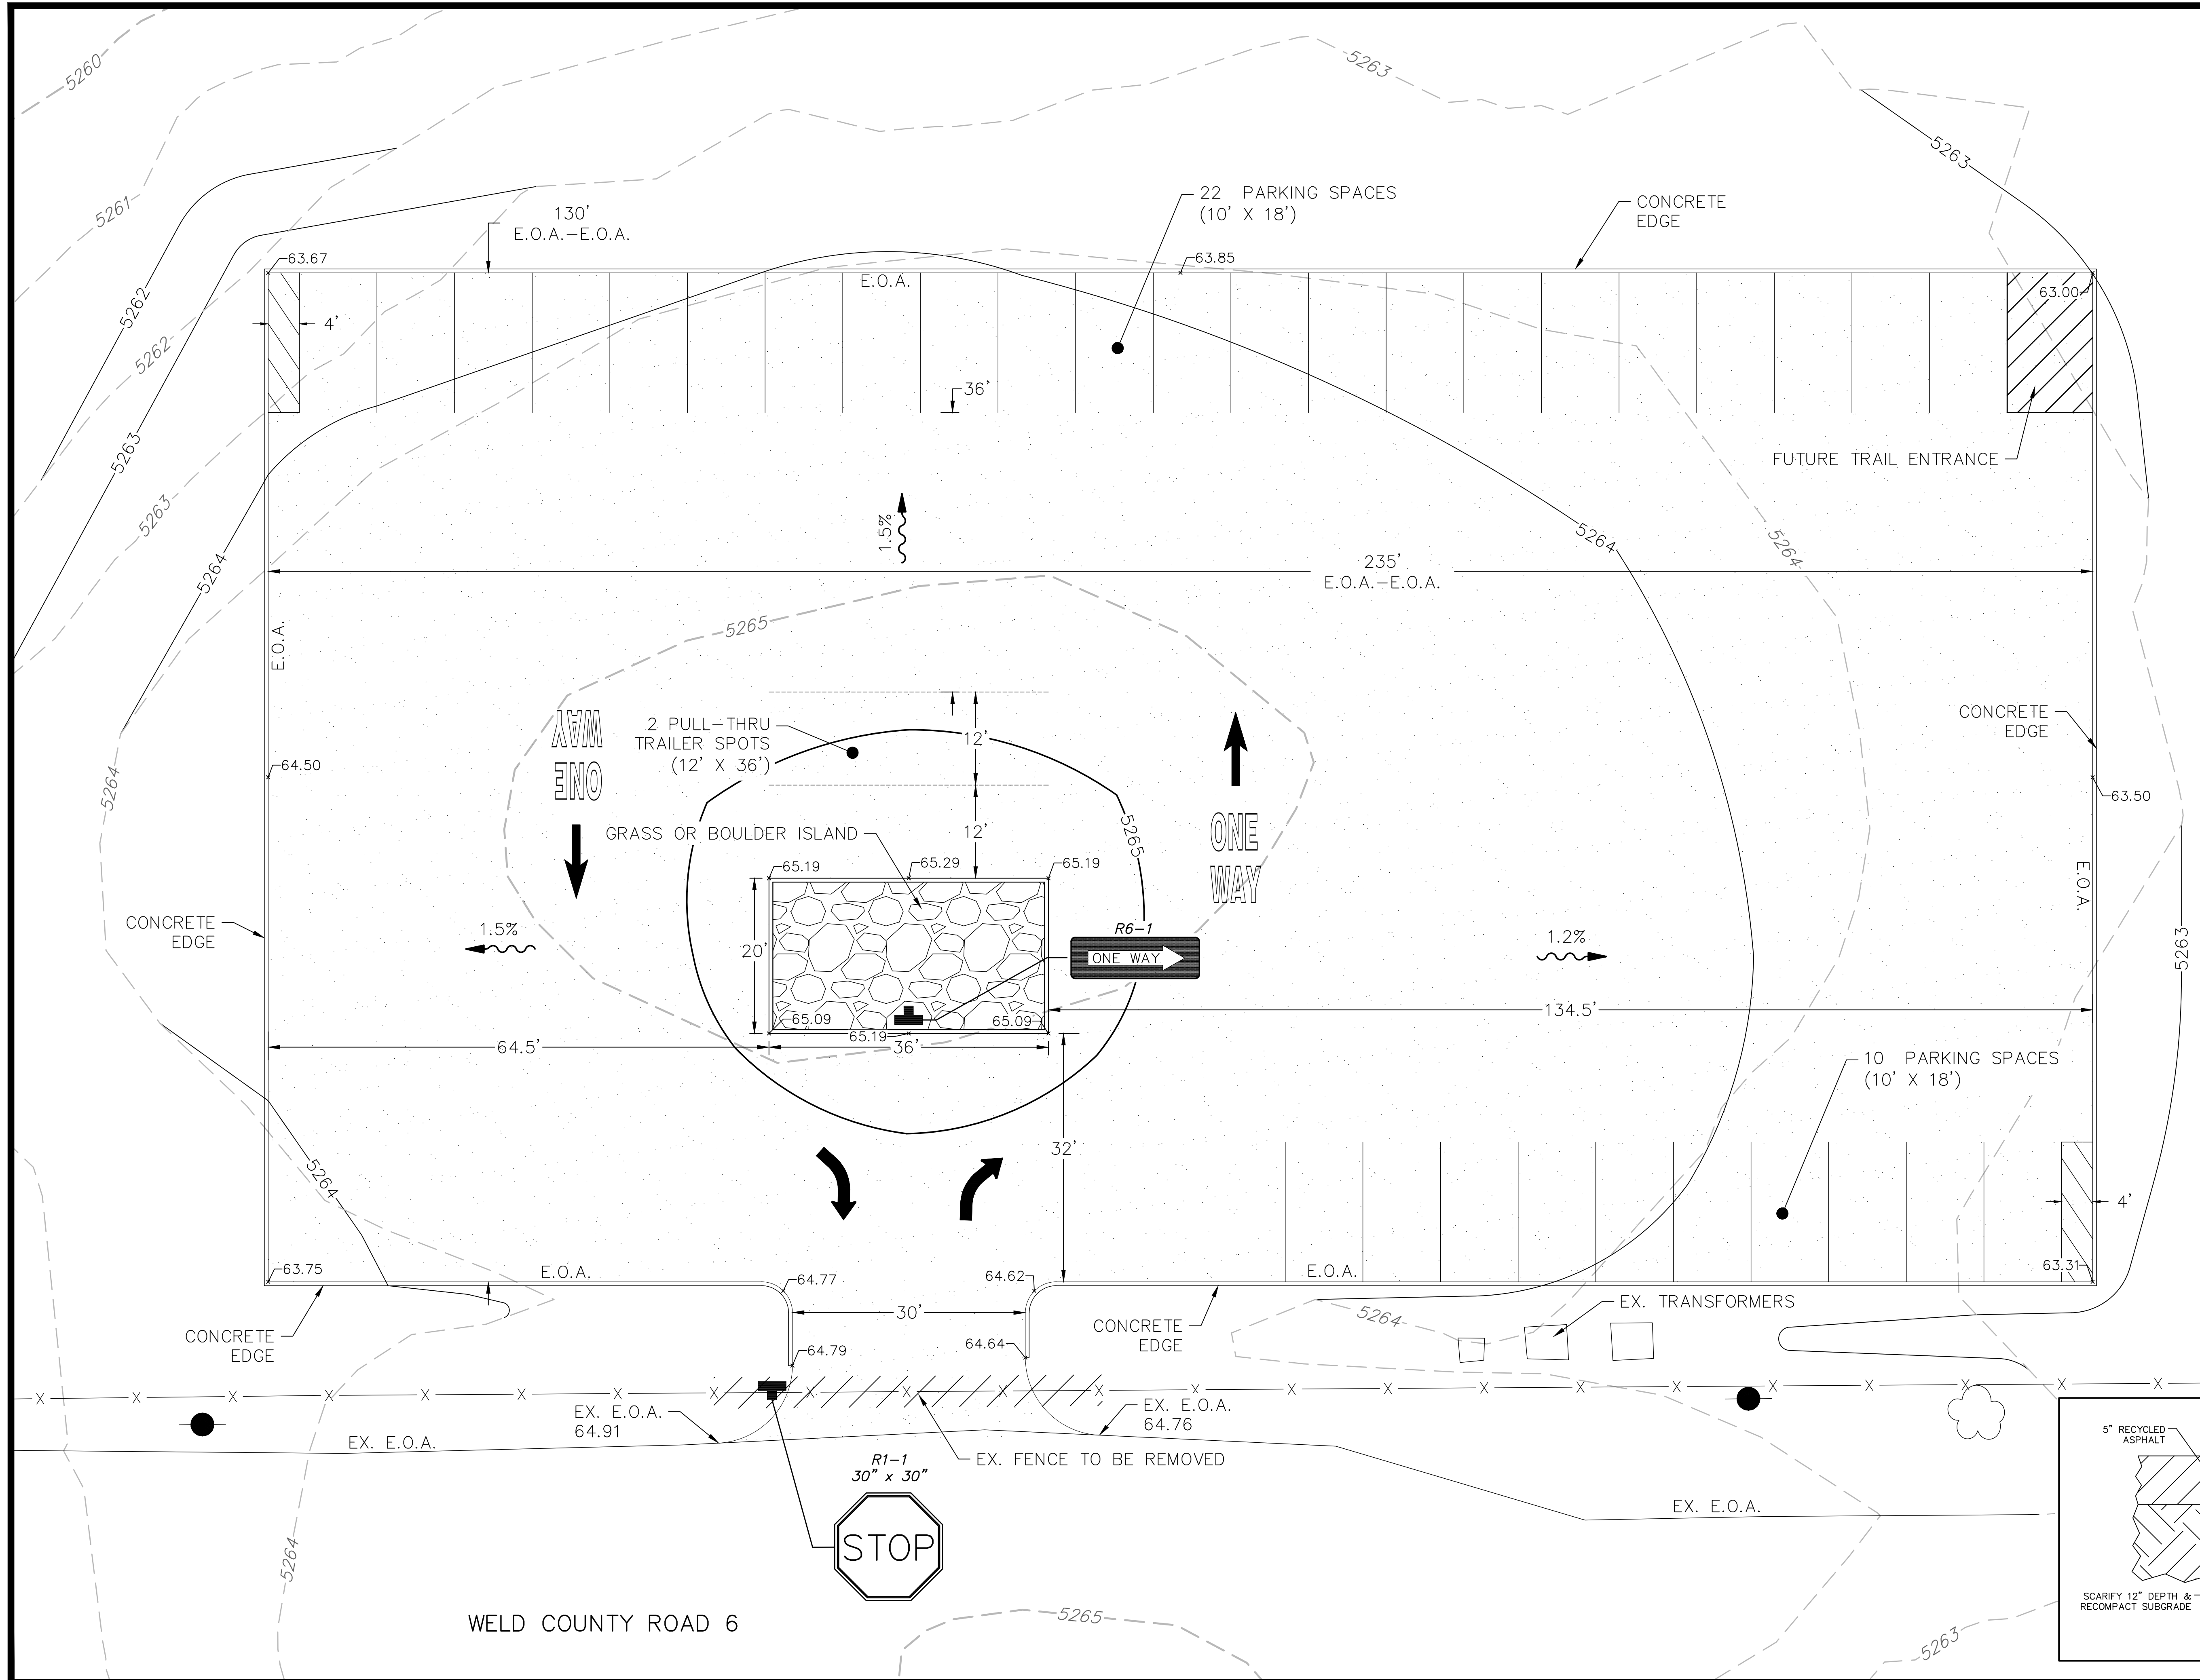


LEGEND

- Proposed Waterline
- Existing Waterline
- Proposed Sewerline
- Existing Sewerline
- Stormline
- Water Service
- Sewer Service
- Fire Service
- Existing Gas Line
- Ex. Underground Electric
- Ex. Overhead Electric
- Existing Fiber Optic
- Existing Telephone Line
- Existing Cable TV Line
- Thrust Block
- Water Valve
- Fire Hydrant
- Plug
- Manhole
- Type 'R' Inlet
- Existing Contours
- Proposed Contours
- Street Light
- Install Handicap Ramp

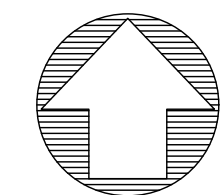

0 10' 20'
SCALE: 1" = 10'

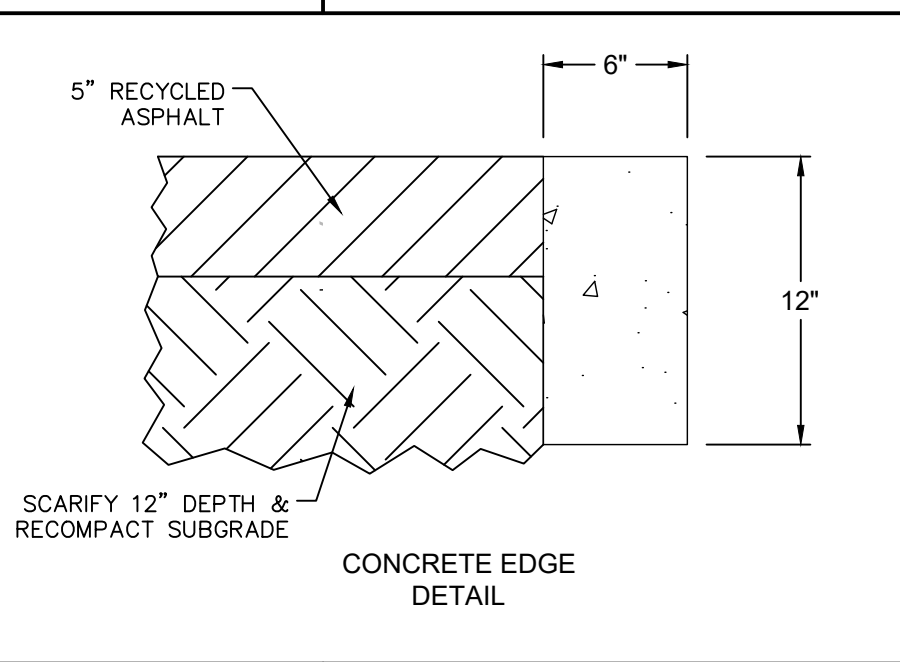

SCALE VERIFICATION

BAR IS ONE INCH
ON ORIGINAL DRAWING
IF NOT ONE INCH ON THIS SHEET
ADJUST SCALES ACCORDINGLY
72 HOURS BEFORE YOU DIG
CALL THE UTILITY NOTIFICATION
CENTER OF COLORADO (1.800.4.A.S.)
811
A.S. IS FOR: TELEPHONE, GAS, AND
POTABLE WATER PIPE LOCATIONS

NO.	DESCRIPTION	DATE	BY
1			

NO.	DESCRIPTION	DATE	BY
1			

HURST & ASSOCIATES, INC.
1265 S. Public Road, Suite B
Lafayette, CO 80026
303.449.9105

HURST
CIVIL ENGINEERING
PLANNING
SURVEYING

MAINTENANCE FACILITY
PARKING LOT
SITE PLAN OPTION 2

Drawn By: JR
Designed By: JJ
Drawing Name: 23318-SITE-2
Approved By: JJ

JOB NUMBER: 2331-8
DATE: 06/06/2018
SCALE: 1" = 10'

SHEET NO: 1